




PORTLAND, CONNECTICUT

NOT VALID WITHOUT SEAL

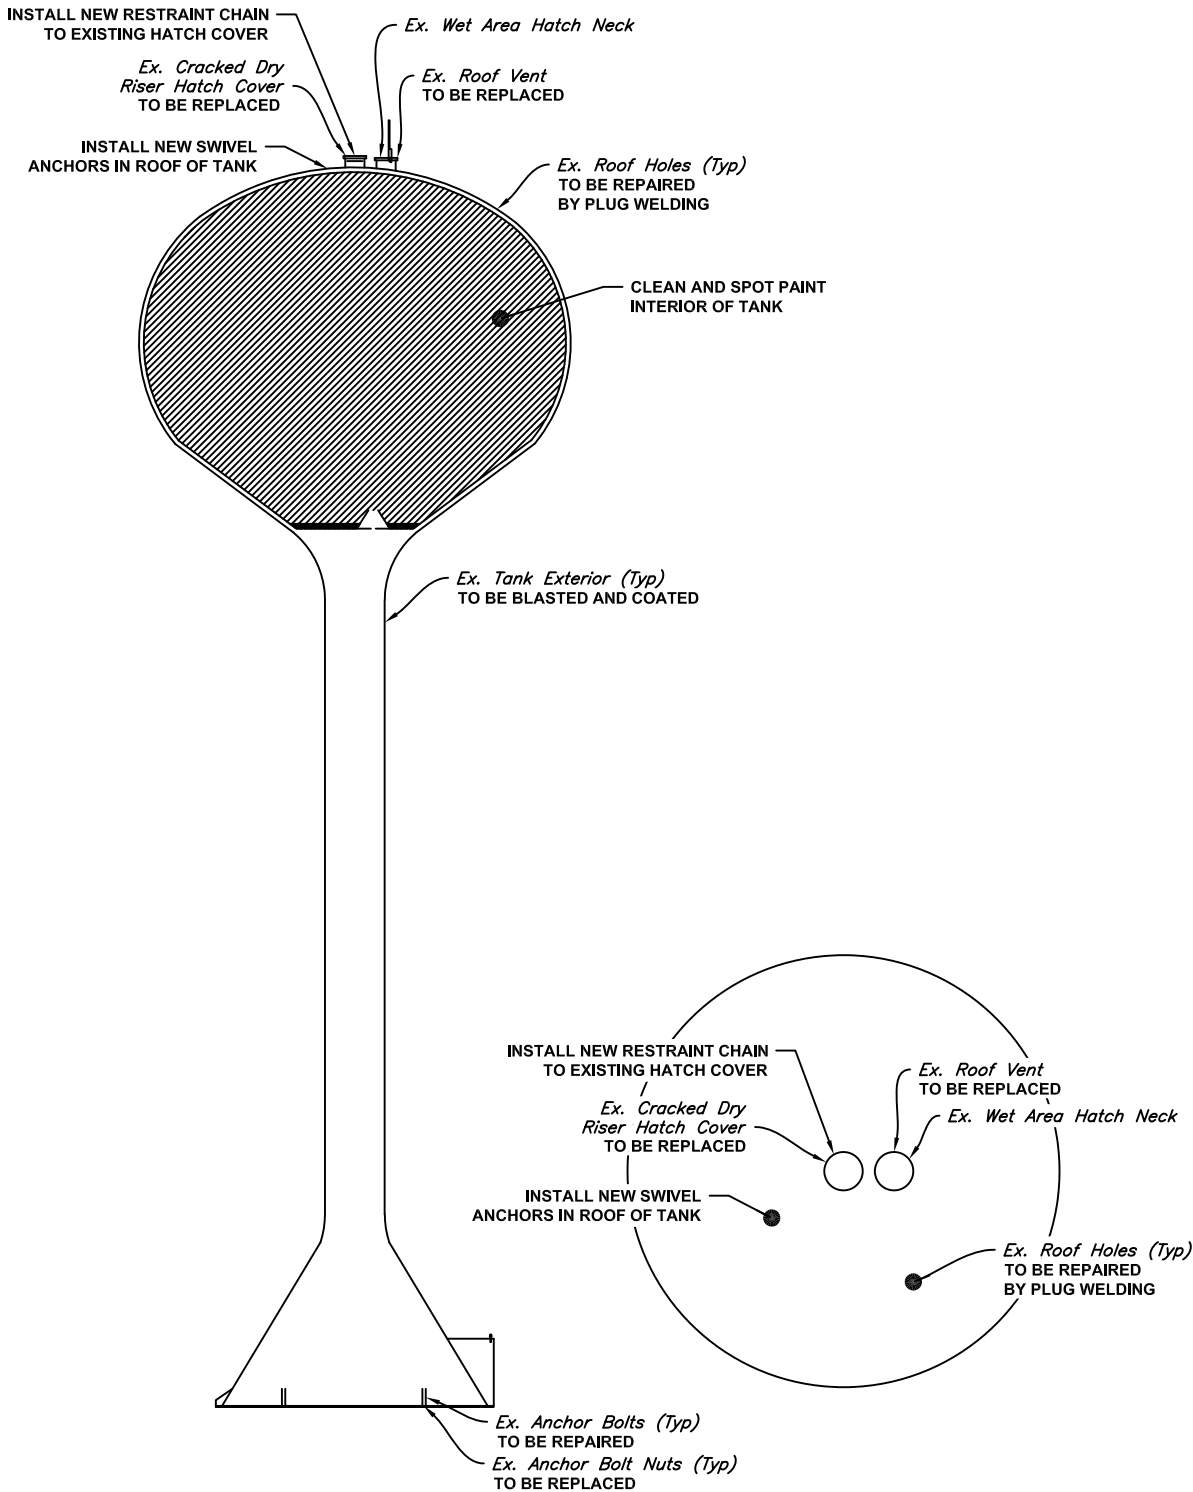

TANK ELEVATION AND ROOF PLANS

SCALE: 1" = 20'

DESIGNED DRS ZAK	DRAWN SLC	CHECKED DRS	REVISED
------------------------	--------------	----------------	---------

PREPARED FOR:  
SOUTH NORWALK  
ELECTRIC & WATER

Norwalk, CT

MICHAEL STREET TANK  
IMPROVEMENTS

New London, Connecticut

A P R I L 2 0 1 9  
SHEET NO. 1 OF 1  
JOB NO. SNEW-001

CONTRACT DRAWING